



ROOF FRAMING PLAN
SCALE: 1/8" = 1'-0"


NOTE:
INSTALL GAS AND WATER LINES OVERHEAD, AND SIZE ACCORDING TO STANDARD PROCEDURE. SIZE WILL BE DETERMINED BY LOCATION OF ENTRY, LENGTH OF RUN, AND PRESSURE REQUIRED.

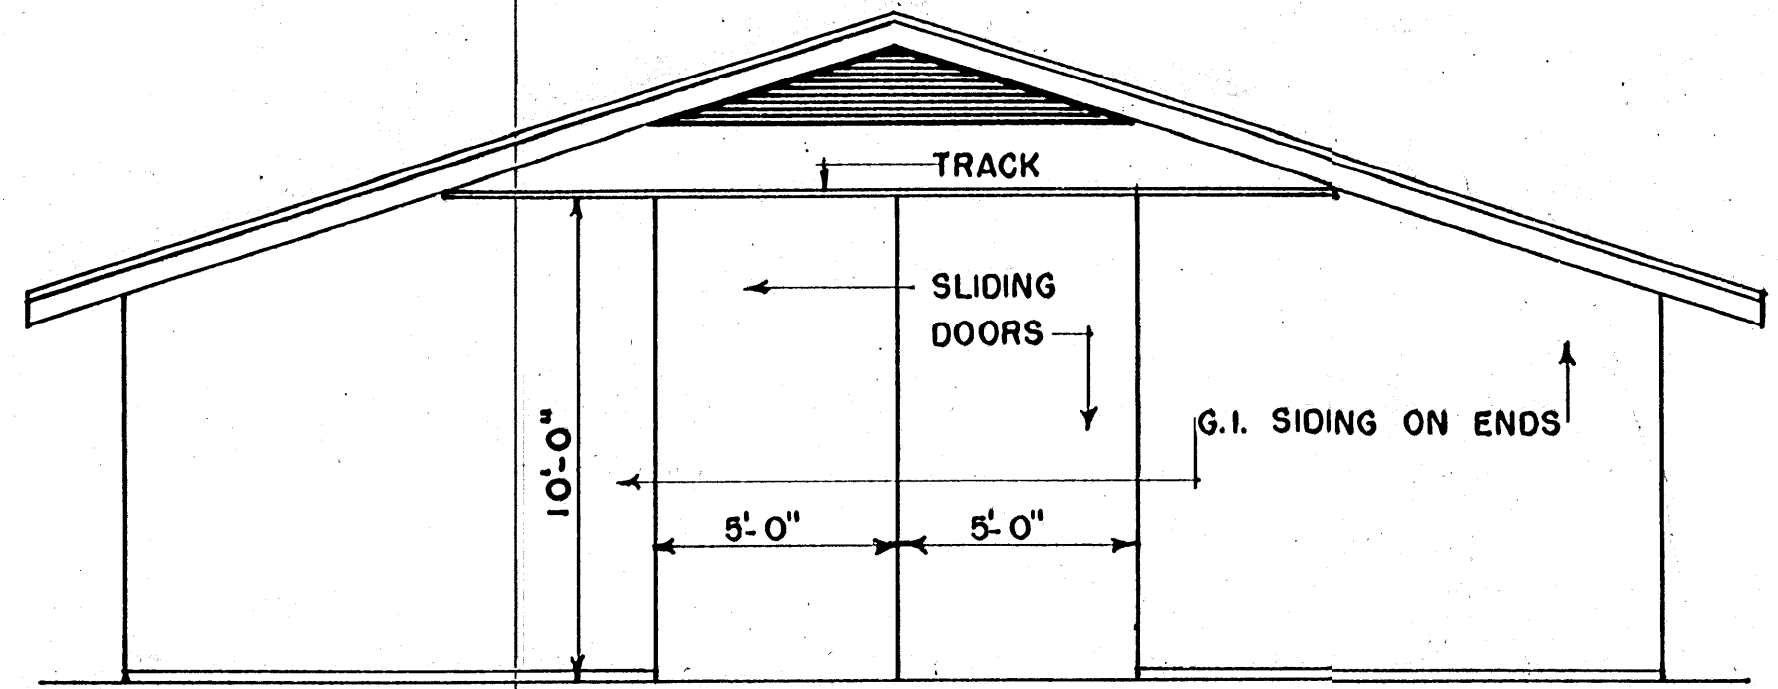


FRONT ELEVATION
SCALE: 1/4" = 1'-0"

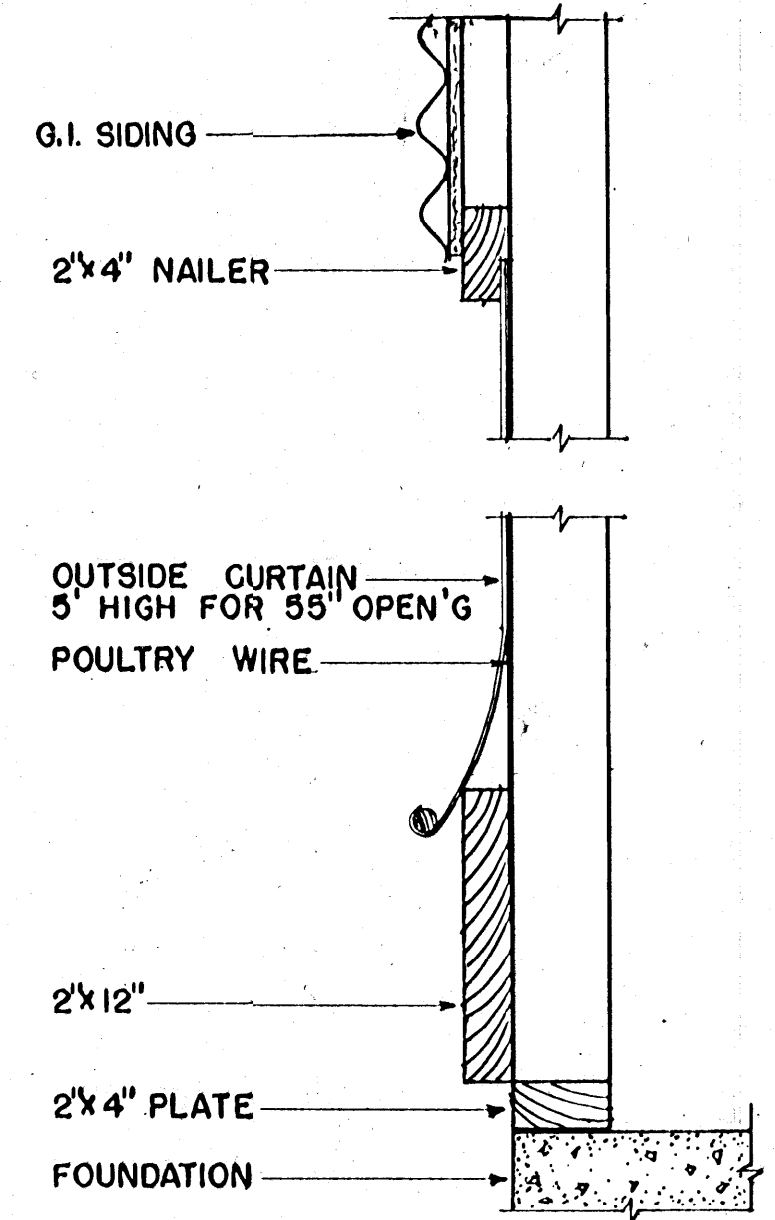

CURTAIN DETAIL
SCALE: 1/2" = 1'-0"

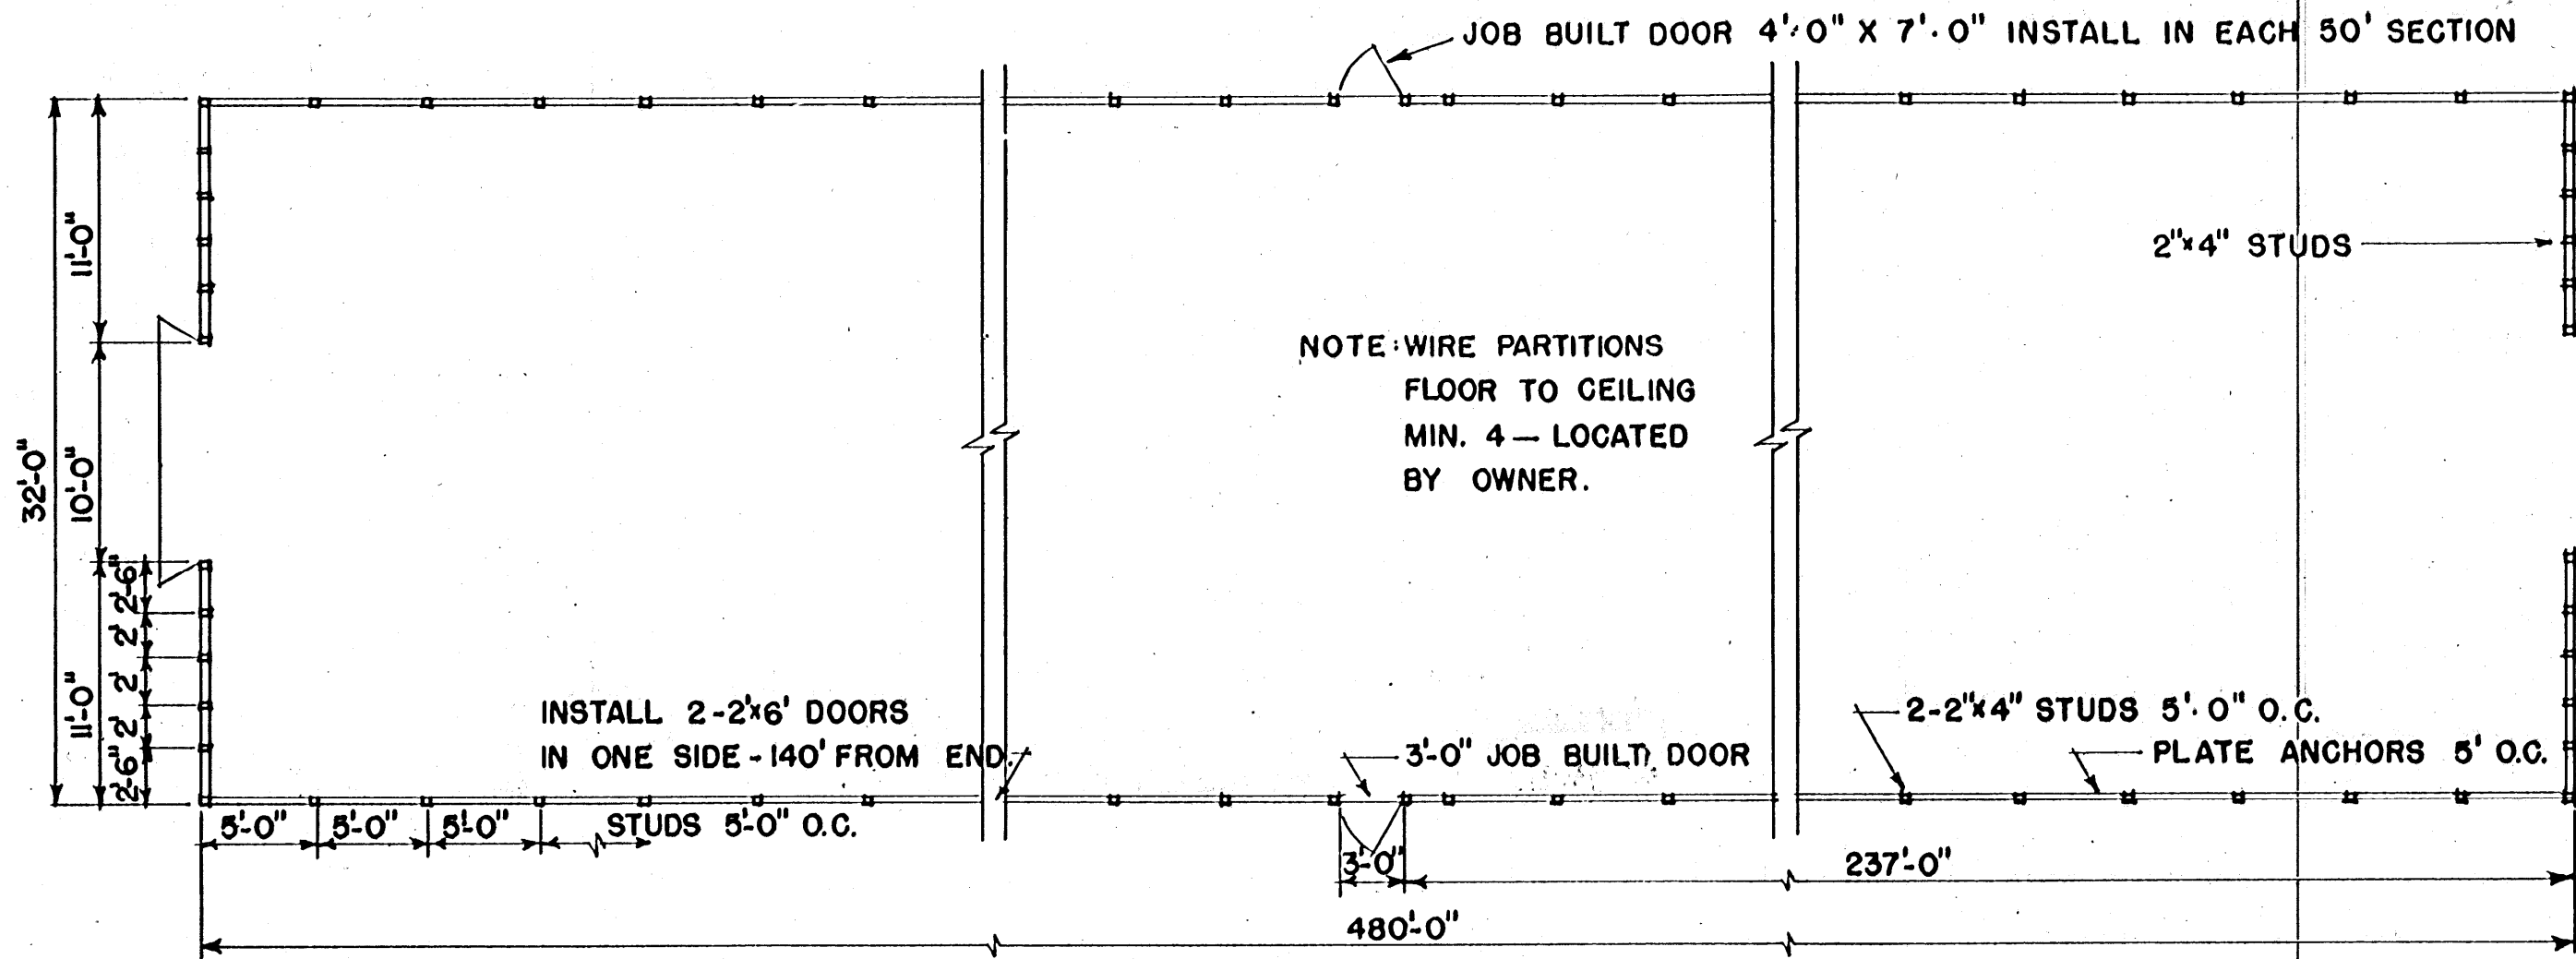

FLOOR PLAN
SCALE: 1/8" = 1'-0"

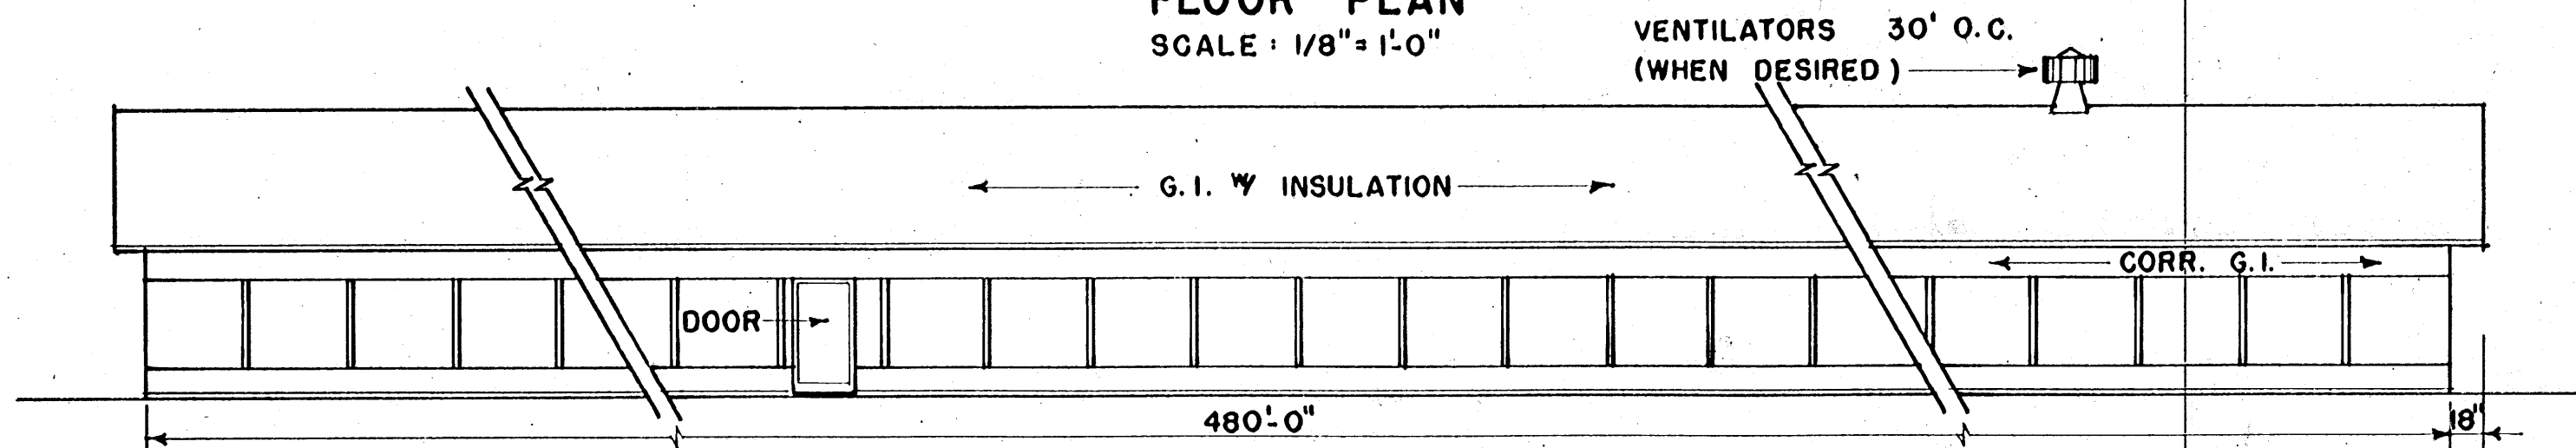


SIDE ELEVATION
SCALE: 1/8" = 1'-0"

TEXAS A&M UNIVERSITY
PLAN NO. 509

COOPERATIVE EXTENSION WORK IN
AGRICULTURE AND HOME ECONOMICS
STATE OF MISSISSIPPI
MISSISSIPPI STATE UNIVERSITY
AND
UNITED STATES DEPARTMENT OF AGRICULTURE COOPERATING


POULTRY HOUSE

TEXAS '69 6085 SHEET, 1 OF 3

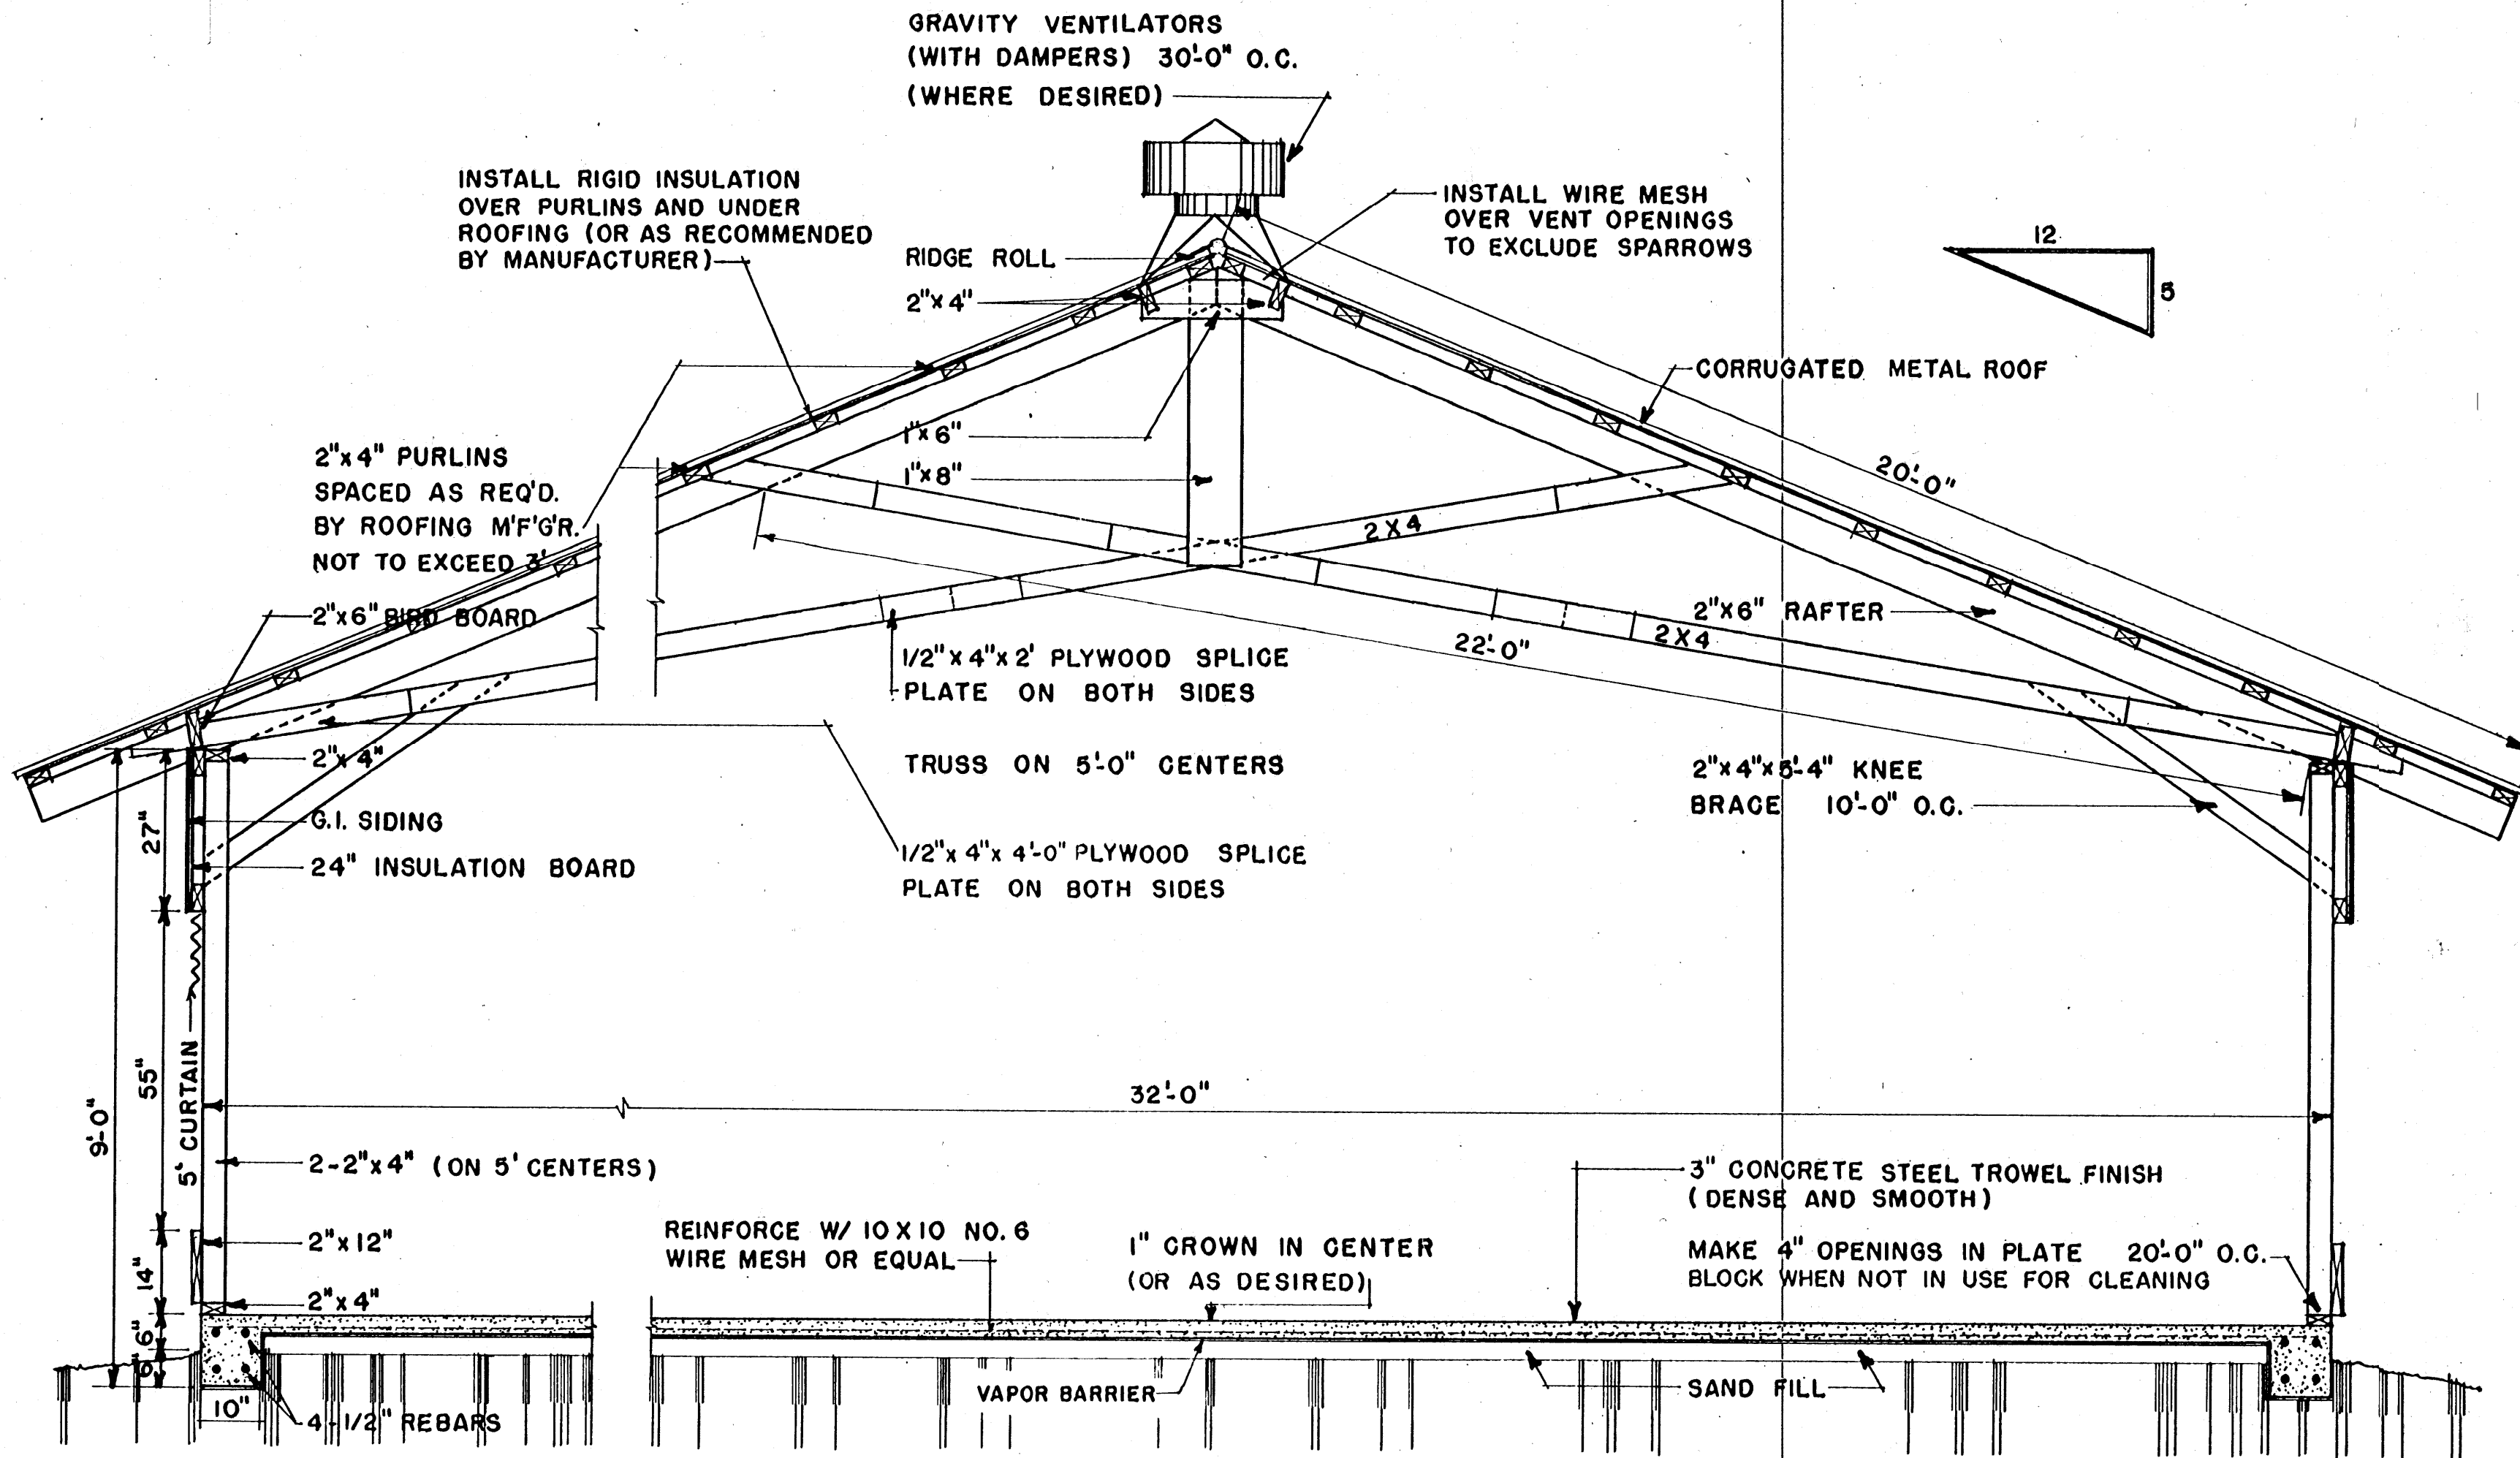


SECTION
SCALE: 1/2" = 1'-0"

| | | |
|--|------|--------------|
| COOPERATIVE EXTENSION WORK IN AGRICULTURE AND HOME ECONOMICS | | |
| STATE OF MISSISSIPPI | | |
| MISSISSIPPI STATE UNIVERSITY | | |
| AND UNITED STATES DEPARTMENT OF AGRICULTURE COOPERATING | | |
| POULTRY HOUSE | | |
| TEXAS '69 | 6085 | SHEET 2 OF 3 |

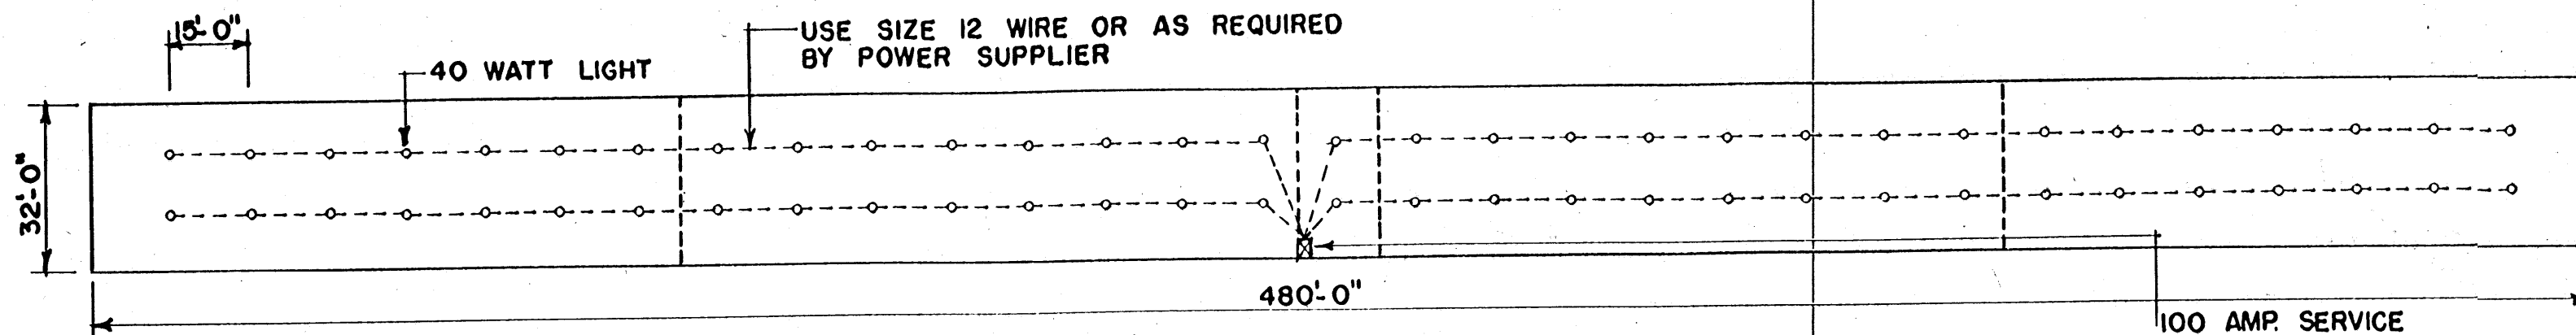

LIGHTING LAYOUT
SCALE: 1" = 30'-0"


100 AMP SERVICE
4-15 AMP. LIGHTING CIRCUITS
2-20 AMP. MOTOR CIRCUITS
1-15 AMP. CIRCUIT-OUTLETS
1 SPARE (MIN.)

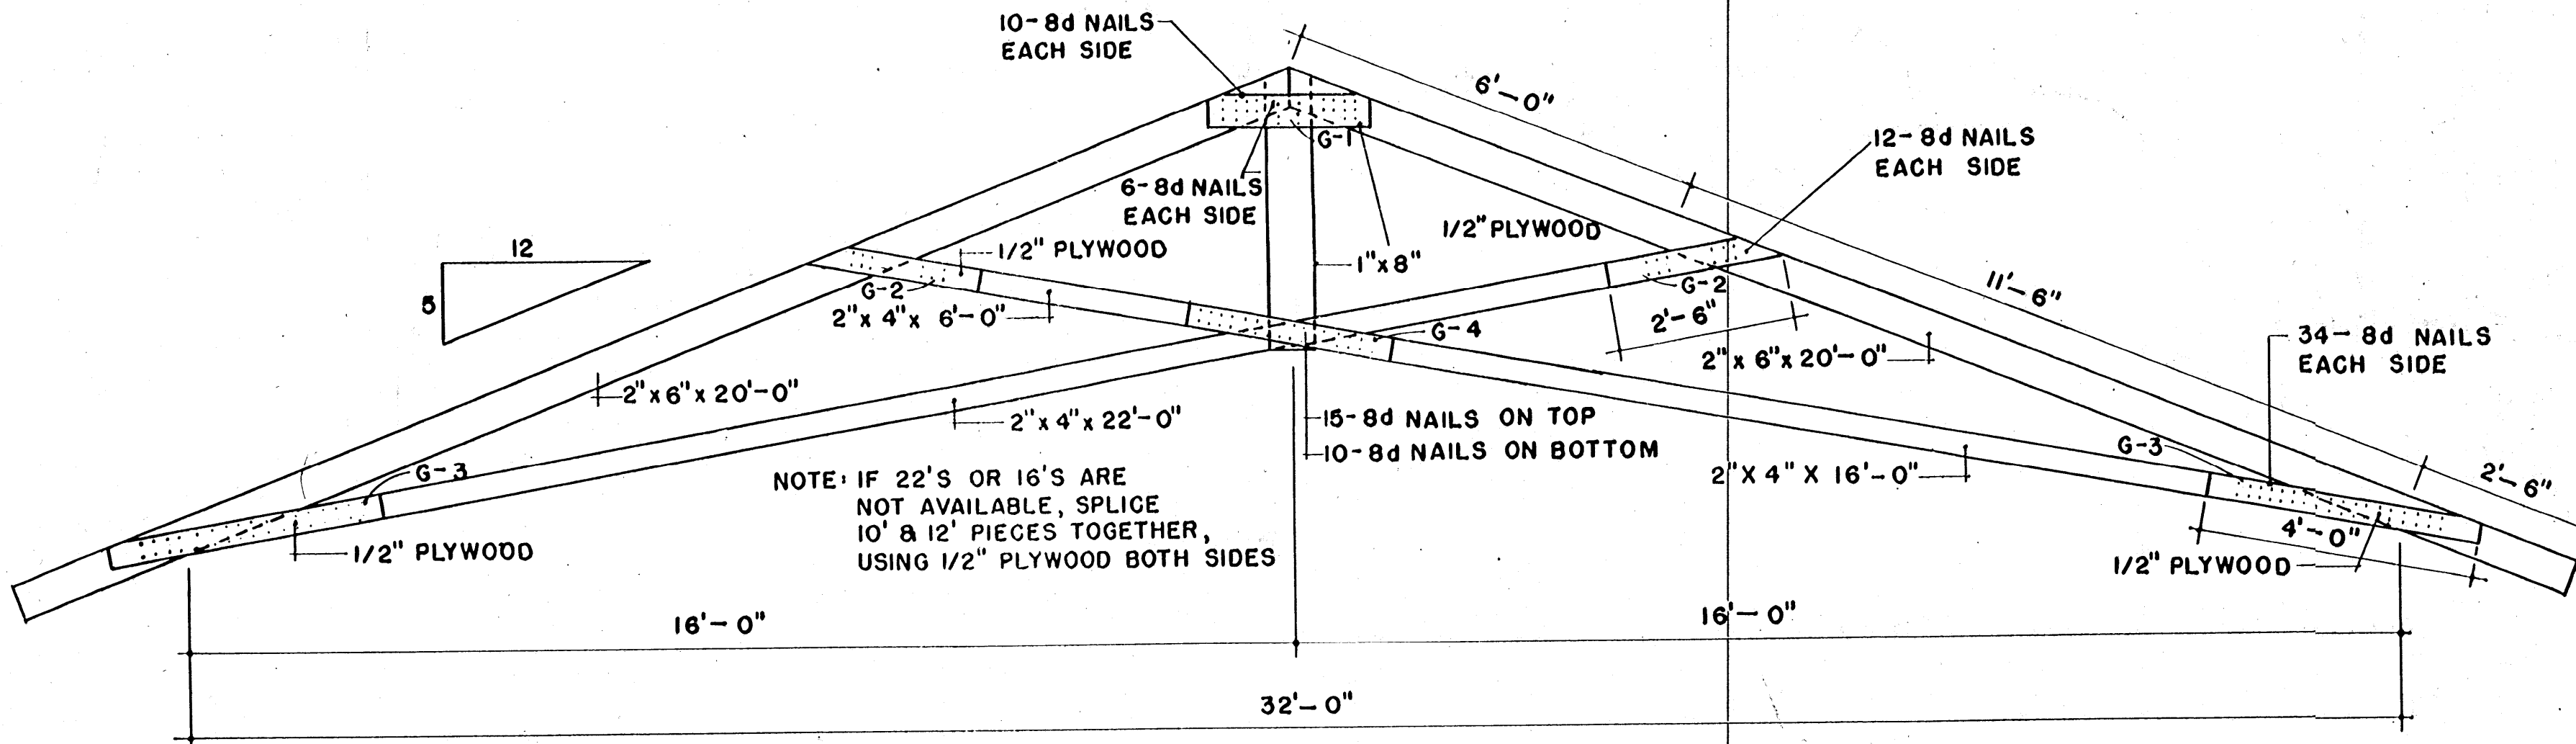


NOTE: HEEL CUTS TO BE MADE AFTER TRUSS IS FABRICATED

FRONT VIEW - TRUSS ASSEMBLY

SCALE 1/2" = 1'-0"

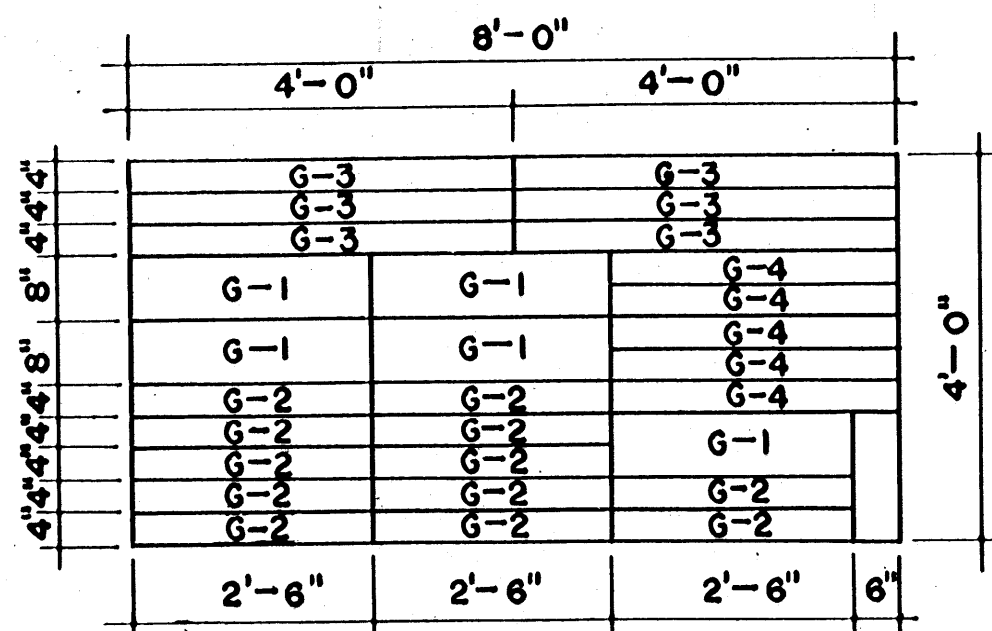

PLYWOOD CUTTING PLAN

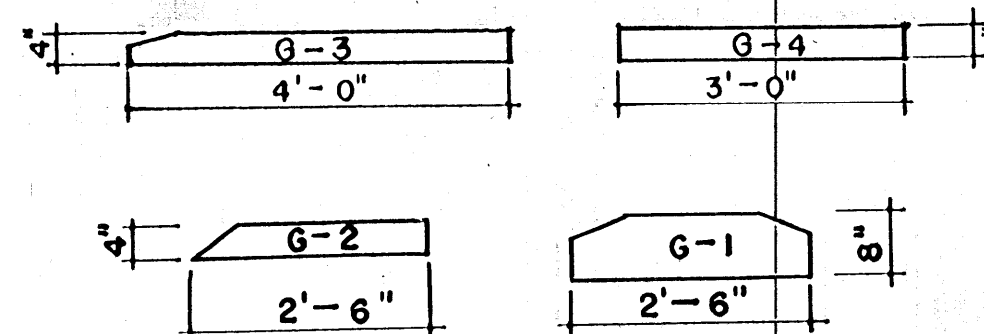

NO. REQ'D PER TRUSS
G-1 = 2
G-2 = 4
G-3 = 4
G-4 = 1

COOPERATIVE EXTENSION WORK IN
AGRICULTURE AND HOME ECONOMICS
STATE OF MISSISSIPPI
MISSISSIPPI STATE UNIVERSITY
AND
UNITED STATES DEPARTMENT OF AGRICULTURE COOPERATING

POULTRY HOUSE

TEXAS '69 6085 SHEET 3 OF 3